


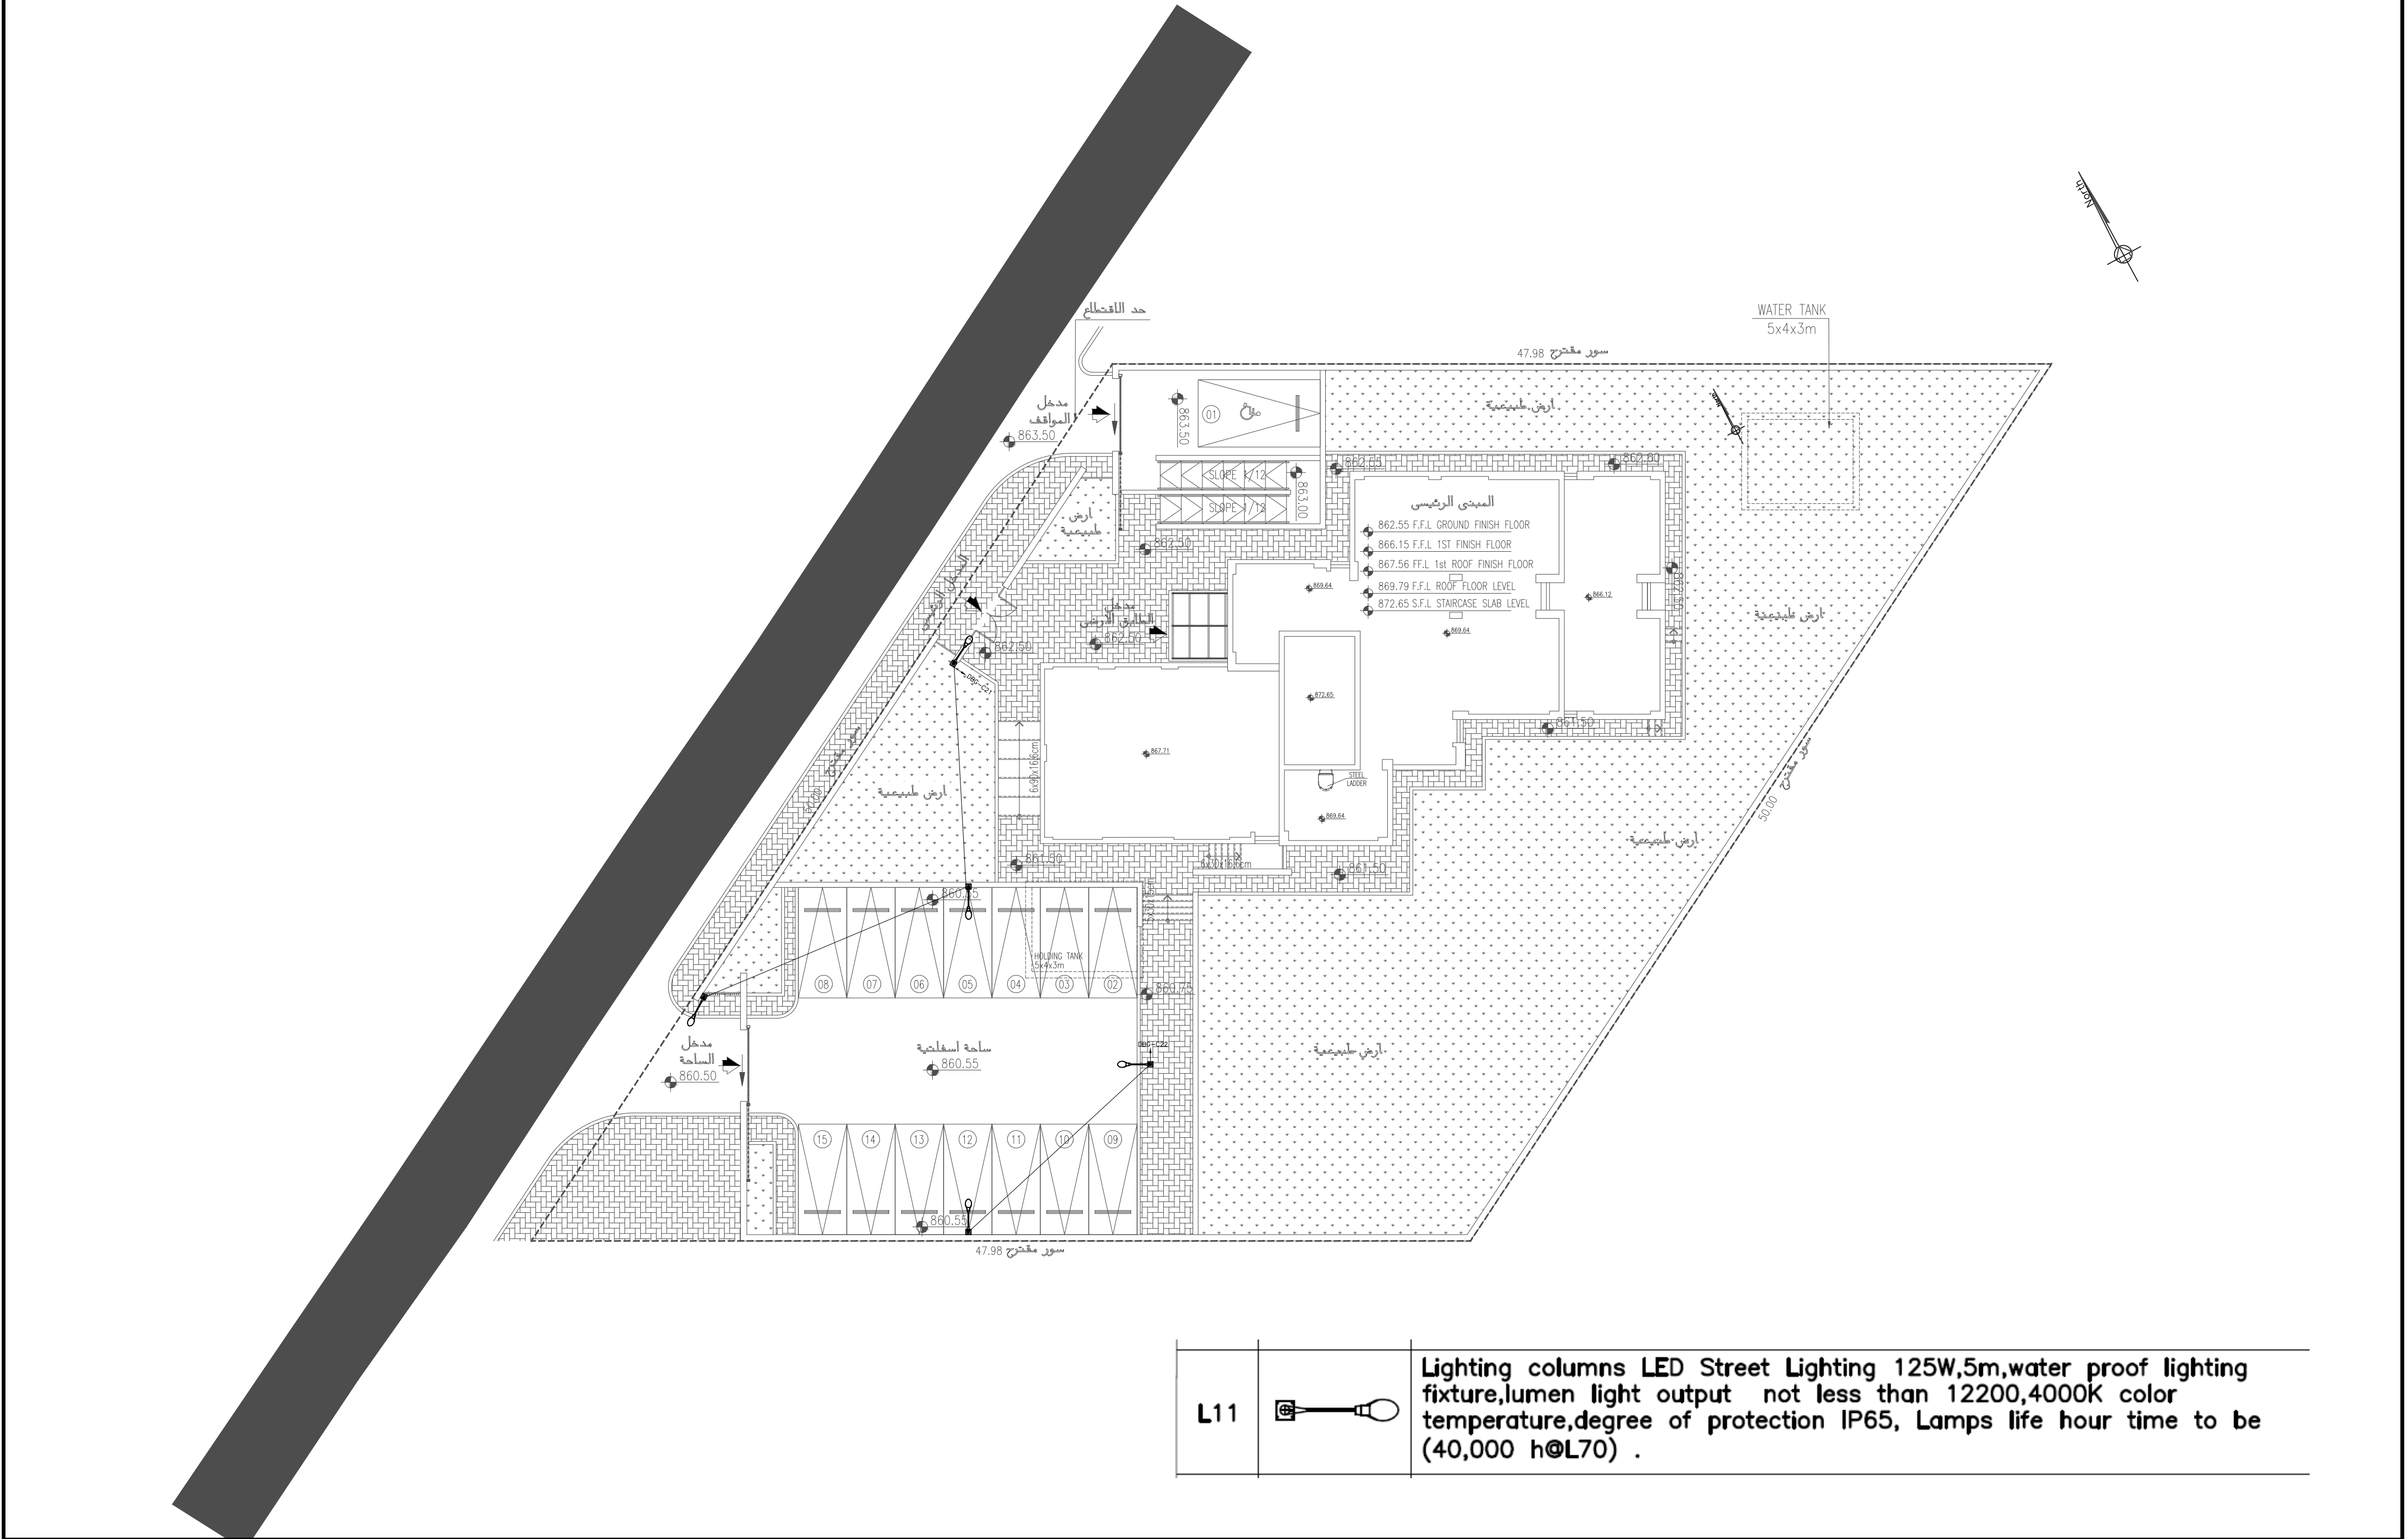

L11		Lighting columns LED Street Lighting 125W,5m,water proof lighting fixture,lumen light output not less than 12200,4000K color temperature,degree of protection IP65, Lamps life hour time to be (40,000 h@L70) .
-----	---	---

NOTES	PROJECT	انشاء مركز شباب منشية بني حسن المفرق	OWNER	LOT No. : 166	BASIN No. : SAWDA AL SHAMALI 61	ENVIRONMENTAL DESIGN GROUP	PROJECT MANAGER	ENG. KHALED H. ZABALAWI	DESIGNED BY	DATE	08/10/2023	PROJECT No.
				وزارة الشباب		edge TEL : + 962 6 5343958 FAX : + 962 6 5343997 P.O.BOX: 551624 AMMAN 11185 JORDAN Email: info@edge-jo.com	DRAWING TITLE	SITE PLAN LIGHTING SYSTEM	DESIGN BY ELECTRICAL TEAM	SCALE	1:200	27
									CHECKED BY ENG. NABEEL AL-ALLAN	DRAWING No.	E00-01-01	
									DRAWN BY ELECTRICAL TEAM			